

PA Procurement Expo September 4-5, 2019 Pennsylvania Farm Show Complex - Main Hall - Level Harrisburg, PA



Show Information	
Show Name	PA Procurement Expo
Show Dates	September 4-5, 2019
Move-In	August 29, 2019
Job #	M144089919
AE	Frank Brown


Options as of 05/14/2019			
Dimension	Size	Qty	SqFt
10'x10'	100	289	28,900
10'x10'	400	5	4,000
20'x20'	200	15	8,000
8'x10'	80	4	3,200
8'x8'	64	108	6,912
Totals:			401 41,732

Floor Plan Legend	
HE	Fire Extinguisher
FS	Fire Stroke
FHC	Fire Hose Cabinet

Venue Info	
Building Name	Pennsylvania Farm Show Complex
Hall	Main Hall
Floor	Level
Address	2307A Cameron St Harrisburg, PA 17110

Drawing Information	
File Path	C:\Users\frank\Documents\PA Procurement Expo - Main Hall.dwg
File Name	PA Procurement Expo - Main Hall.dwg
Drawn By	RP
Last Saved	6/20/19 9:40 AM
Saved By	RP
Tab	Floorplan
Paper Size	(11.00 x 17.00) ANSI
Scale	NTS

1531 Carroll Drive NW
Atlanta, GA 30376
(770) 404-7260
(770) 404-7260-9730

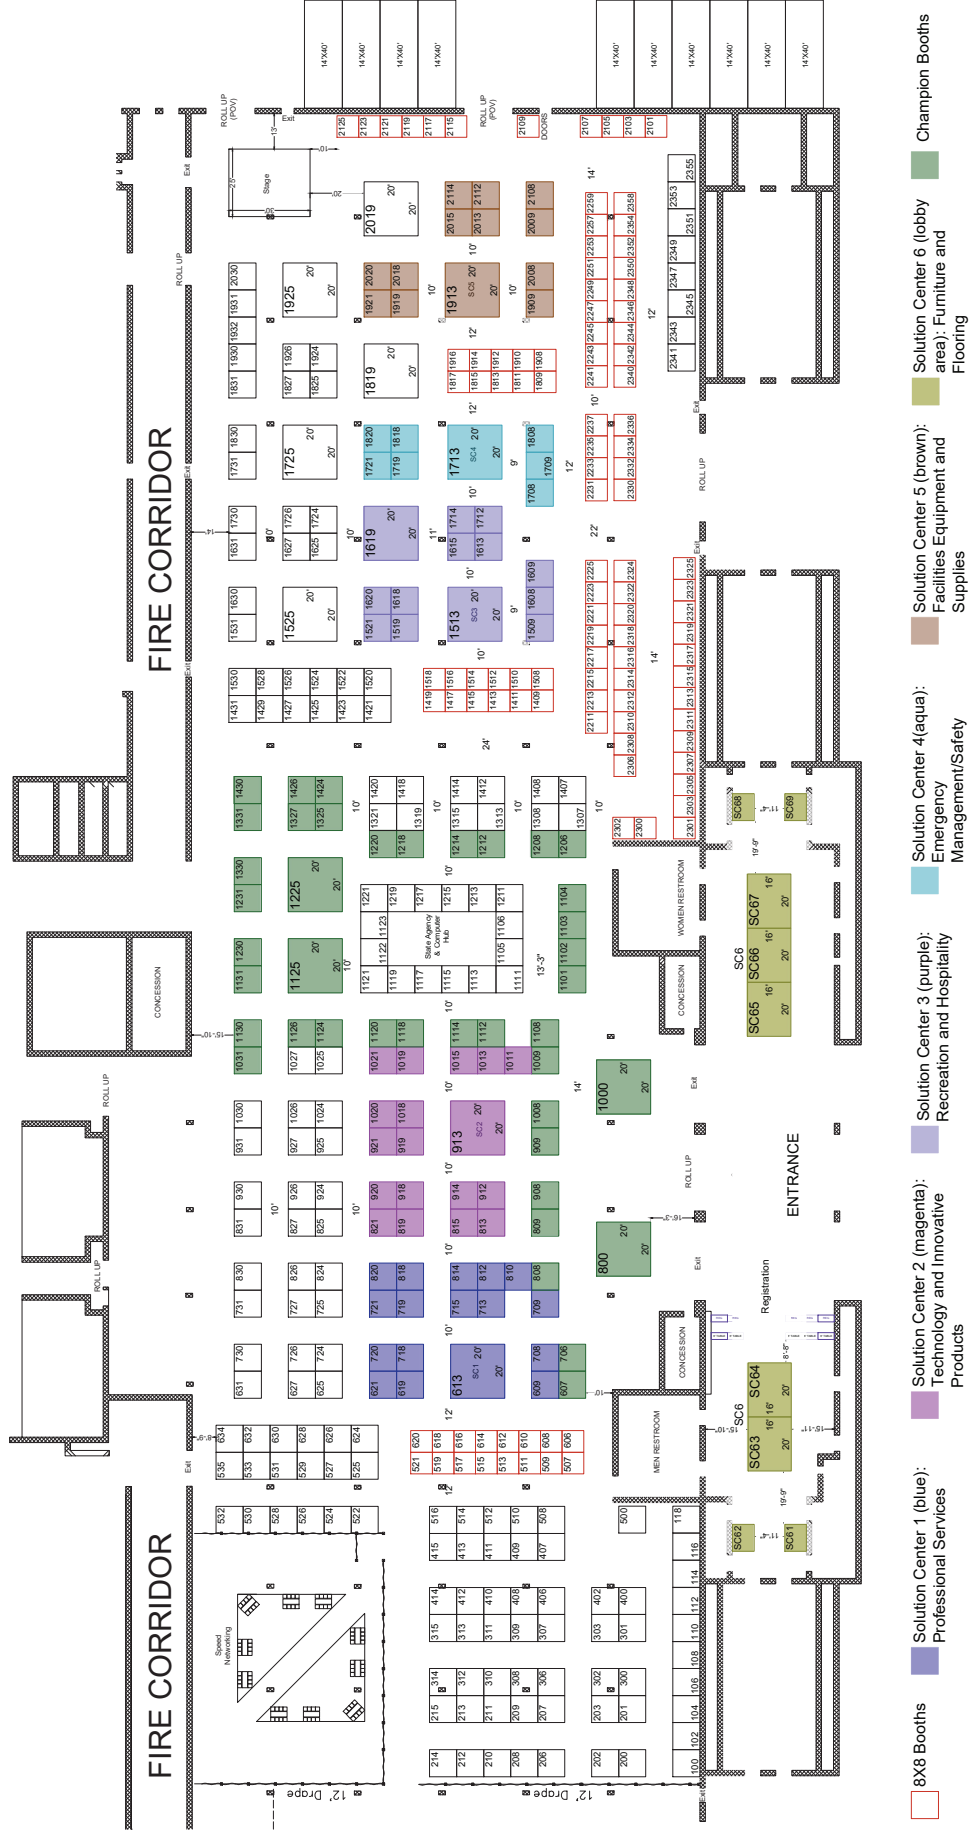

- 8x8 Booths
- Solution Center 1 (blue): Professional Services
- Solution Center 2 (magenta): Technology and Innovative Products
- Solution Center 3 (purple): Recreation and Hospitality
- Solution Center 4 (cyan): Emergency Management/Safety
- Solution Center 5 (brown): Facilities Equipment and Supplies
- Solution Center 6 (lobby area): Furniture and Flooring
- Champion Booths

Shepard Exposition Services has made every effort to ensure the accuracy of all information contained on this floor plan. However, no warranties, either expressed or implied, are made with respect to this floor plan. Verifying the locations of building columns, utilities, or other architectural components of the facility is the sole responsibility of the exhibitor/show management.

SUBJECT TO FIRE MARSHAL APPROVAL